

LEGEND:


- RECESSED CAN
- CF CAN FAN
- ⊗ DECORATIVE FIXTURE
- WALL MOUNT FIXTURE
- ✦ FAN W/O LIGHT KIT
- ▬ FLORESCENT LIGHT STRIP
- ~ PULL WIRE

NOTES:

ALL LIGHTING TO BE 2700K- 3000K

ALL RECESSED CANS, UNDER CABINET LIGHTING, FLORESCENT LIGHT STRIPS PER G.C.

ALL LIGHTING TO BE INSTALLED PER G.C.

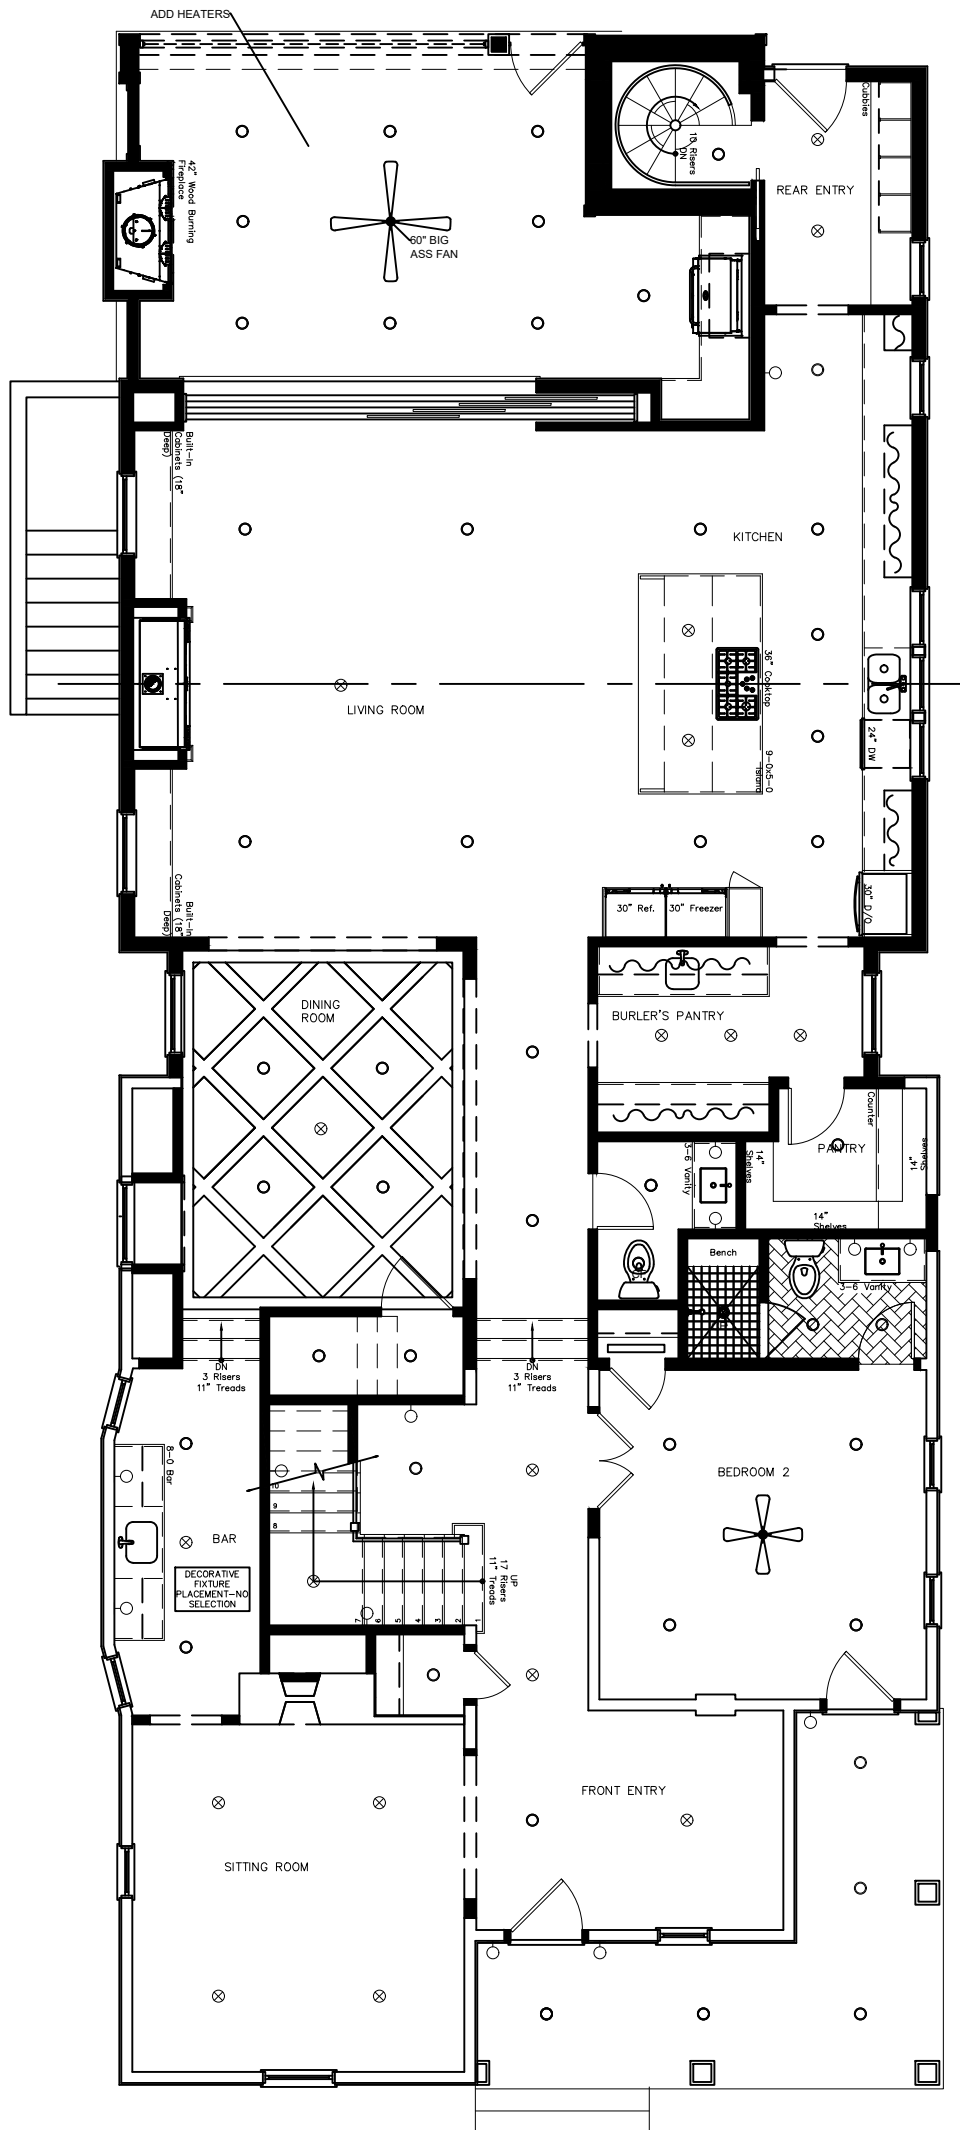

1ST FLOOR LIGHTING PLAN

SCALE: $\frac{1}{8}'' = 1'$

LEGEND:


- RECESSED CAN
- /CF CAN FAN
- ⊗ DECORATIVE FIXTURE
- /H WALL MOUNT FIXTURE
- ⊗ FAN W/O LIGHT KIT
- FLORESCENT LIGHT STRIP
- ~ PULL WIRE

NOTES:

ALL LIGHTING TO BE 2700K- 3000K

ALL RECESSED CANS, UNDER CABINET LIGHTING, FLORESCENT LIGHT STRIPS PER G.C.

ALL LIGHTING TO BE INSTALLED PER G.C.

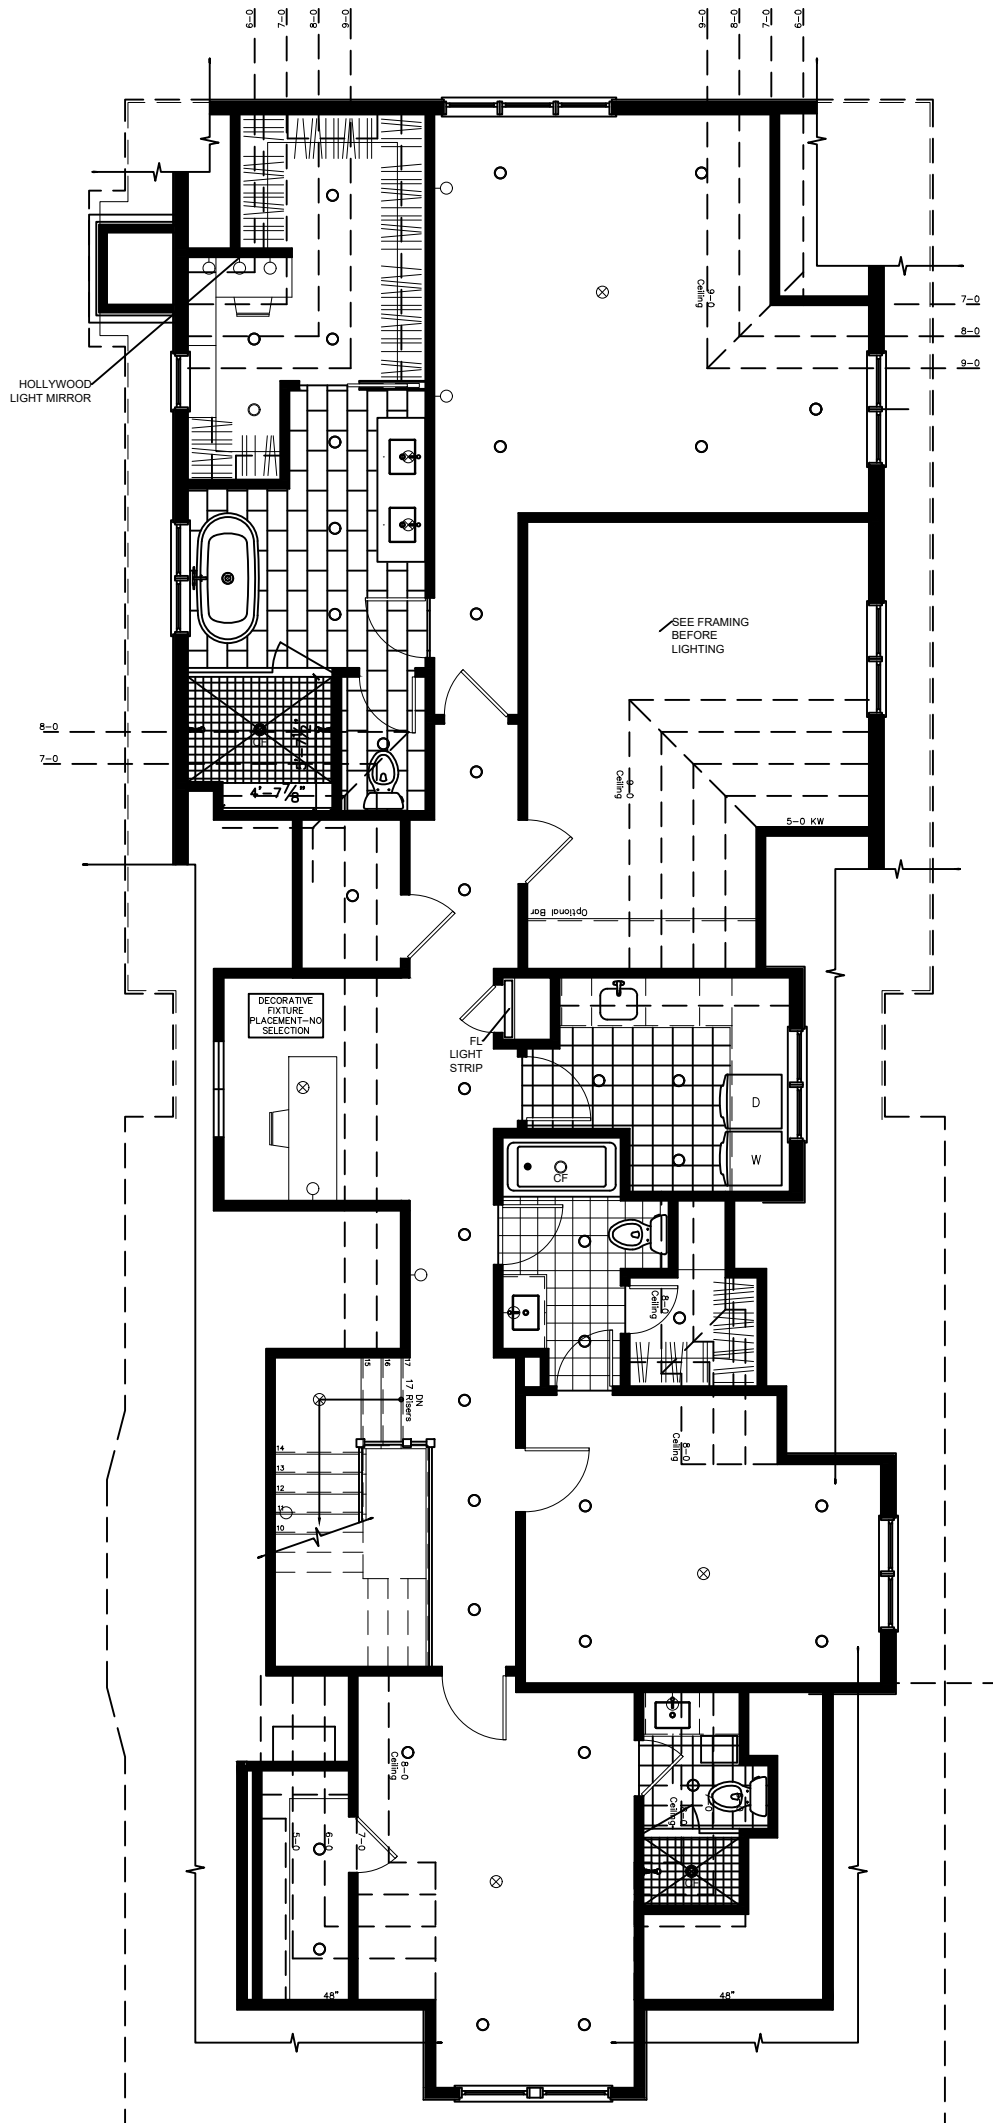

2ND FLOOR RCP
 SCALE: 1/8" = 1'